



THIS DRAWING IS THE COPYRIGHT OF ORANGE KEY LTD. IT IS PRIVATE AND CONFIDENTIAL AND IS SUPPLIED ON THE EXPRESS CONDITION THAT IT IS NOT USED FOR ANY PURPOSE OR COPIED OR COMMUNICATED TO ANY OTHER PARTY WITHOUT THE WRITTEN CONSENT OF ORANGE KEY LTD.

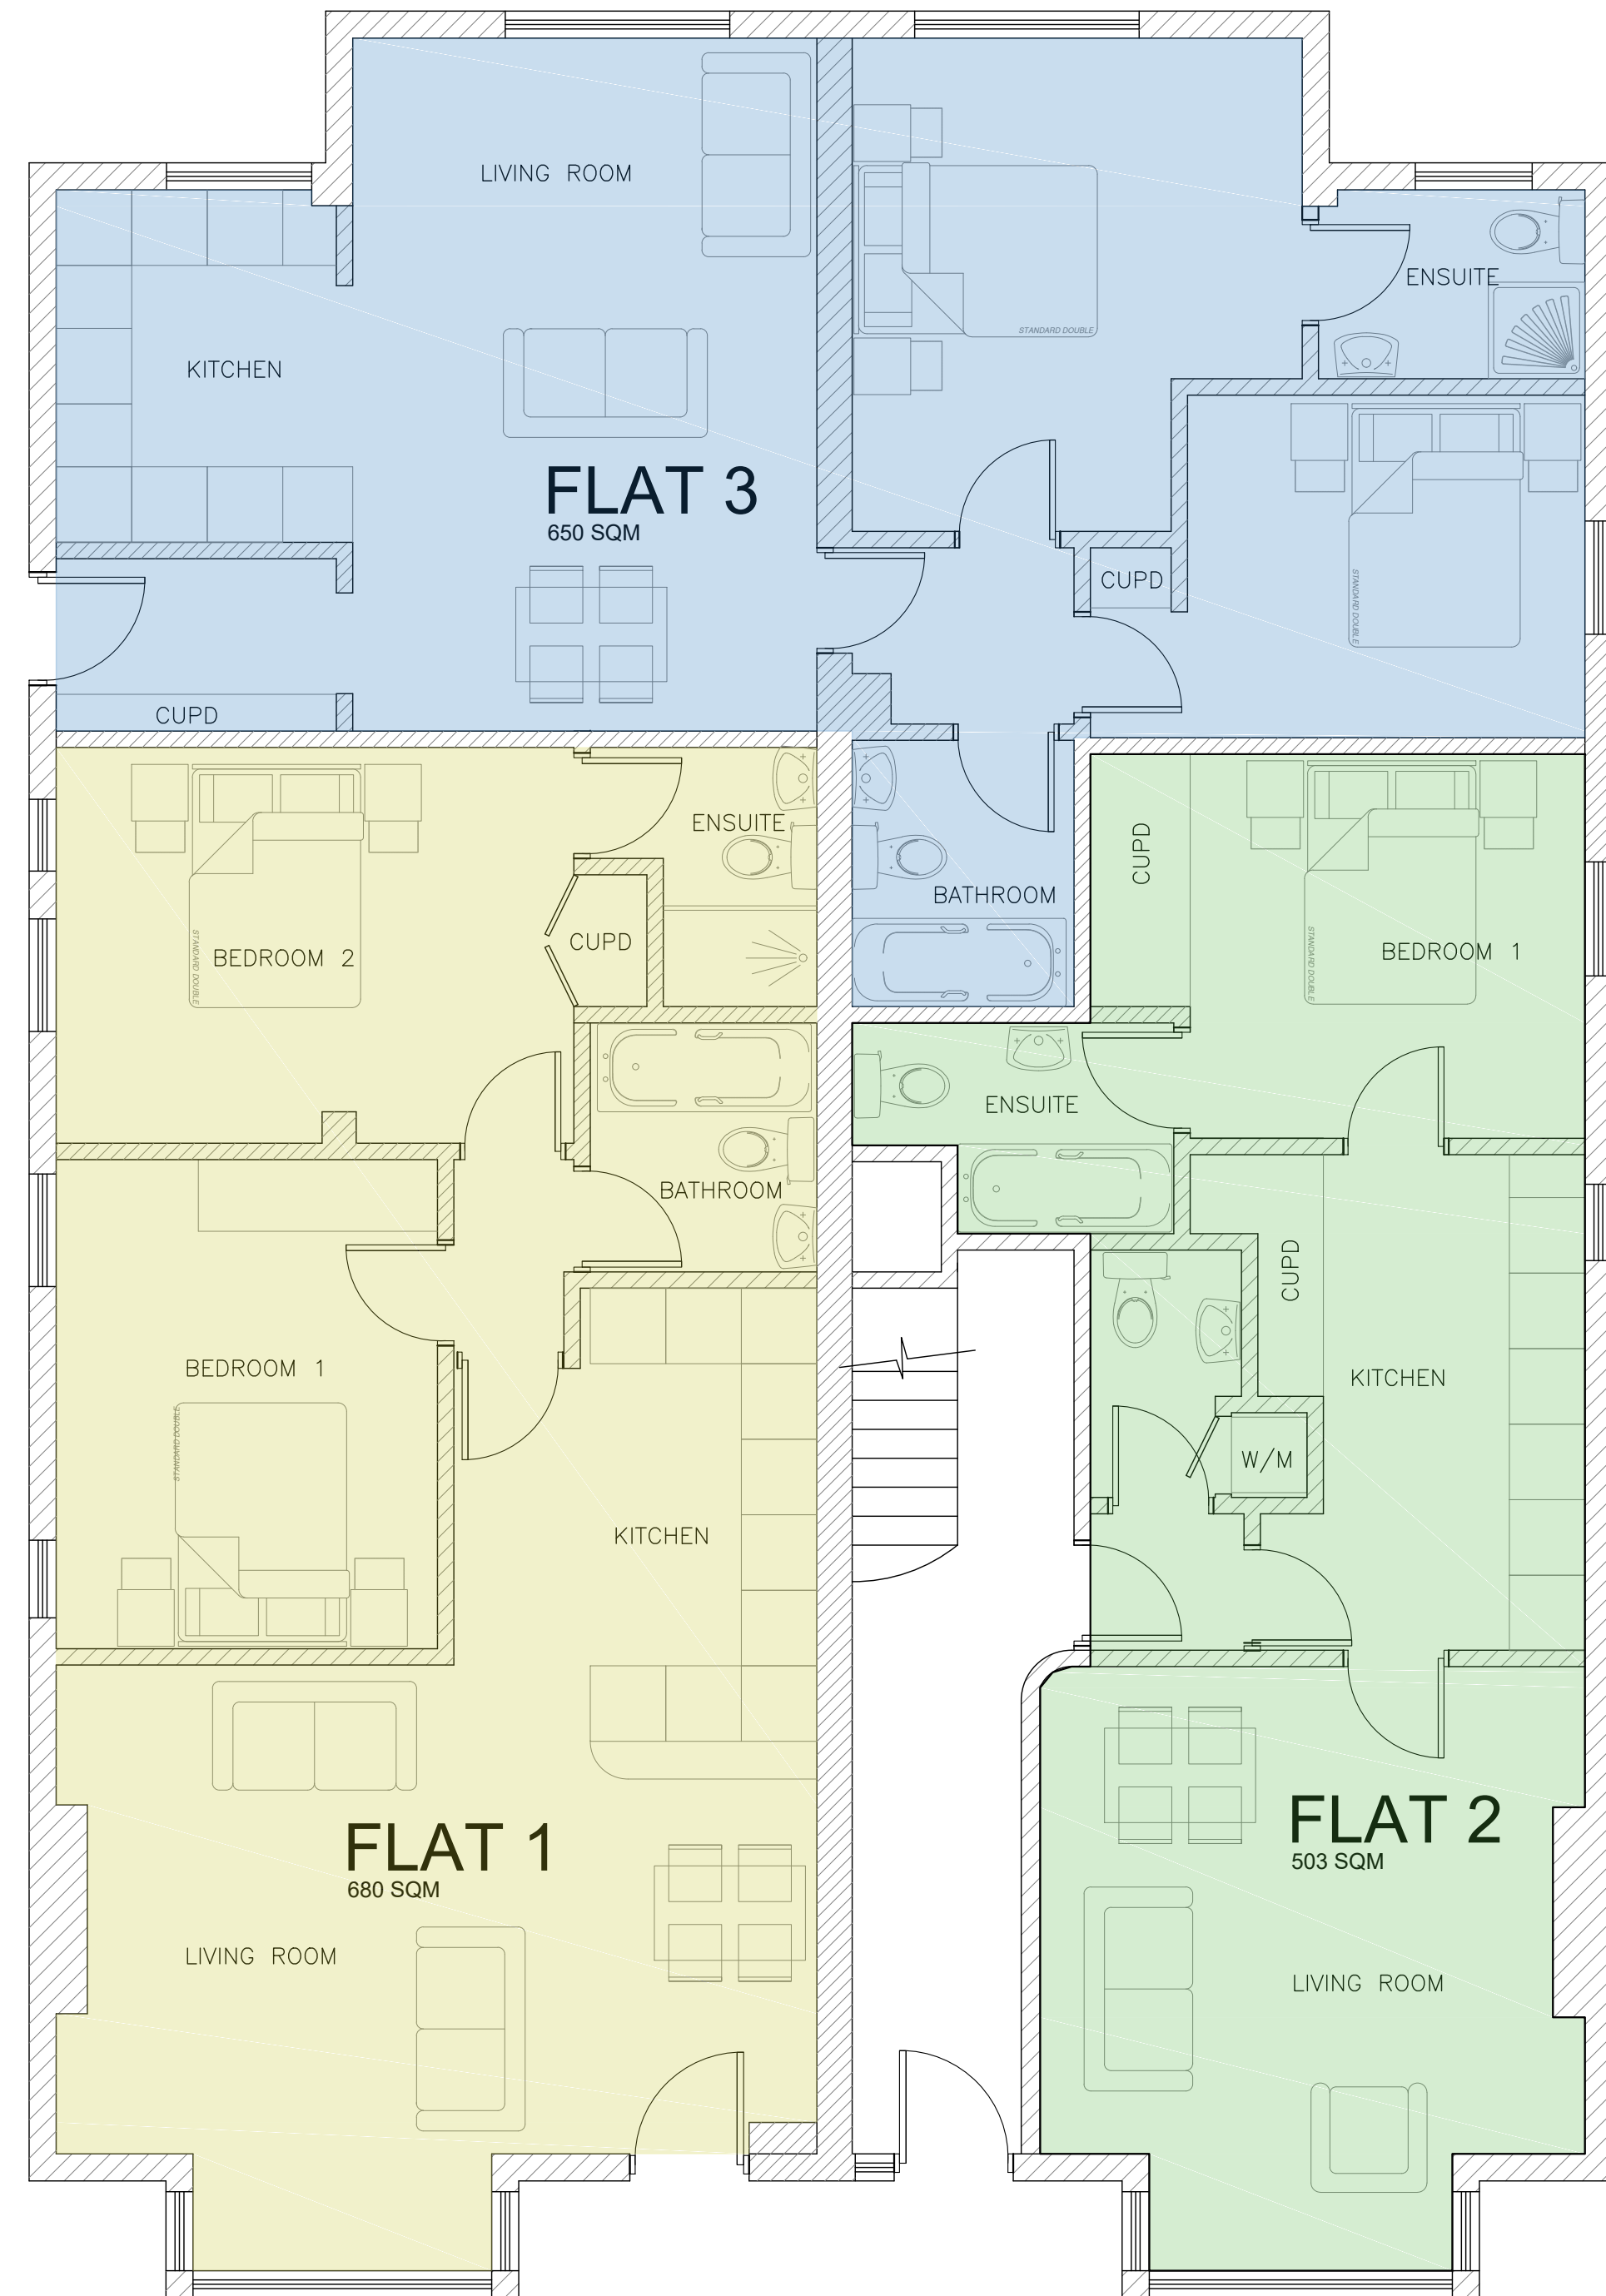

PROPOSED GROUND FLOOR LAYOUT
SCALE 1:50

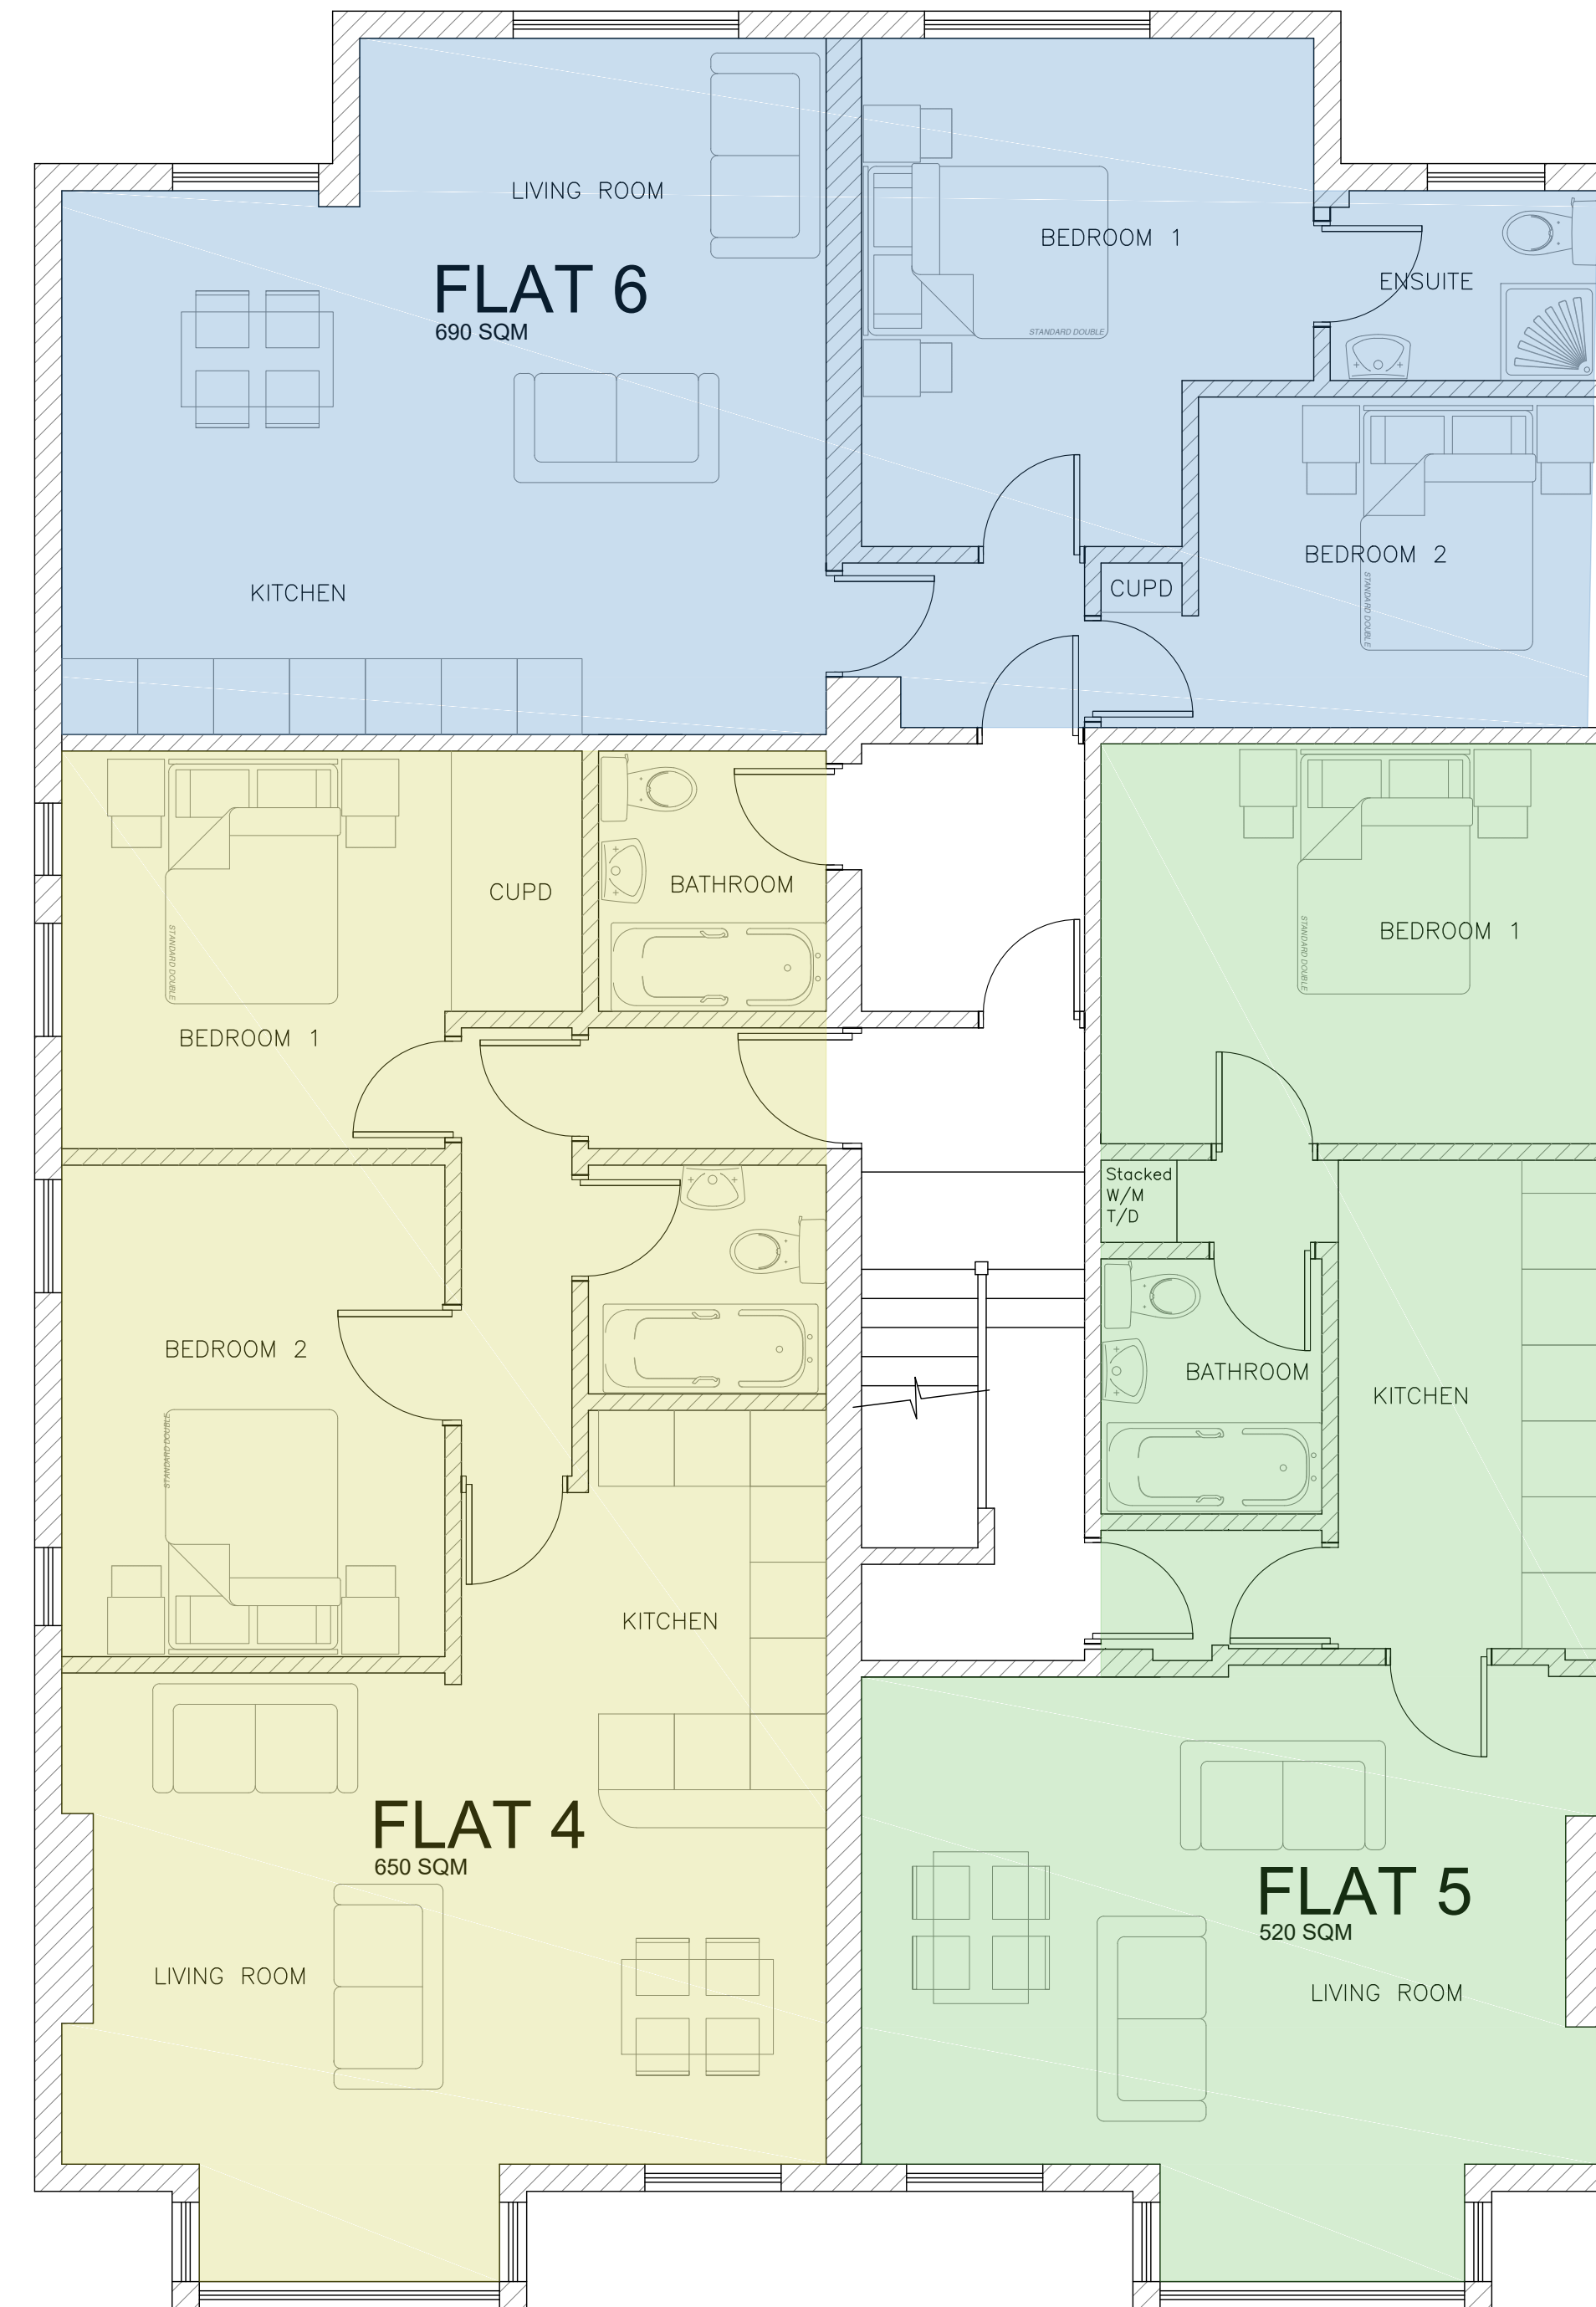

PROPOSED FIRST FLOOR LAYOUT
SCALE 1:50

REFERENCE DRAWINGS			
REV	DATE	REVISION	OR REVIEW

Orange Key
 Unit 4, The Cuttings
 120 High Street, Hungerford
 Berkshire, RG17 0LU
 Tel: (01488) 662918
 E-mail: info@orangekeyltd.co.uk

Client
CASTLE HOMES (LONDON) LTD

Project
**106-108 ST LEONARDS ROAD
WINDSOR
SL4 3DD**

Title
**PROPOSED GROUND AND FIRST
FLOOR LAYOUT**


Scale AS SHOWN @ A1 Date JAN 2016

Originator Reviewed By GEL


Drawing number 16004/001 Rev. P4

ORIGINAL SCALE 0-100mm

THIS DRAWING IS THE COPYRIGHT OF ORANGE KEY LTD. IT IS PRIVATE AND CONFIDENTIAL AND IS SUPPLIED ON THE EXPRESS CONDITION THAT IT IS NOT USED FOR ANY PURPOSE OR COPIED OR COMMUNICATED TO ANY OTHER PARTY WITHOUT THE WRITTEN CONSENT OF ORANGE KEY LTD.

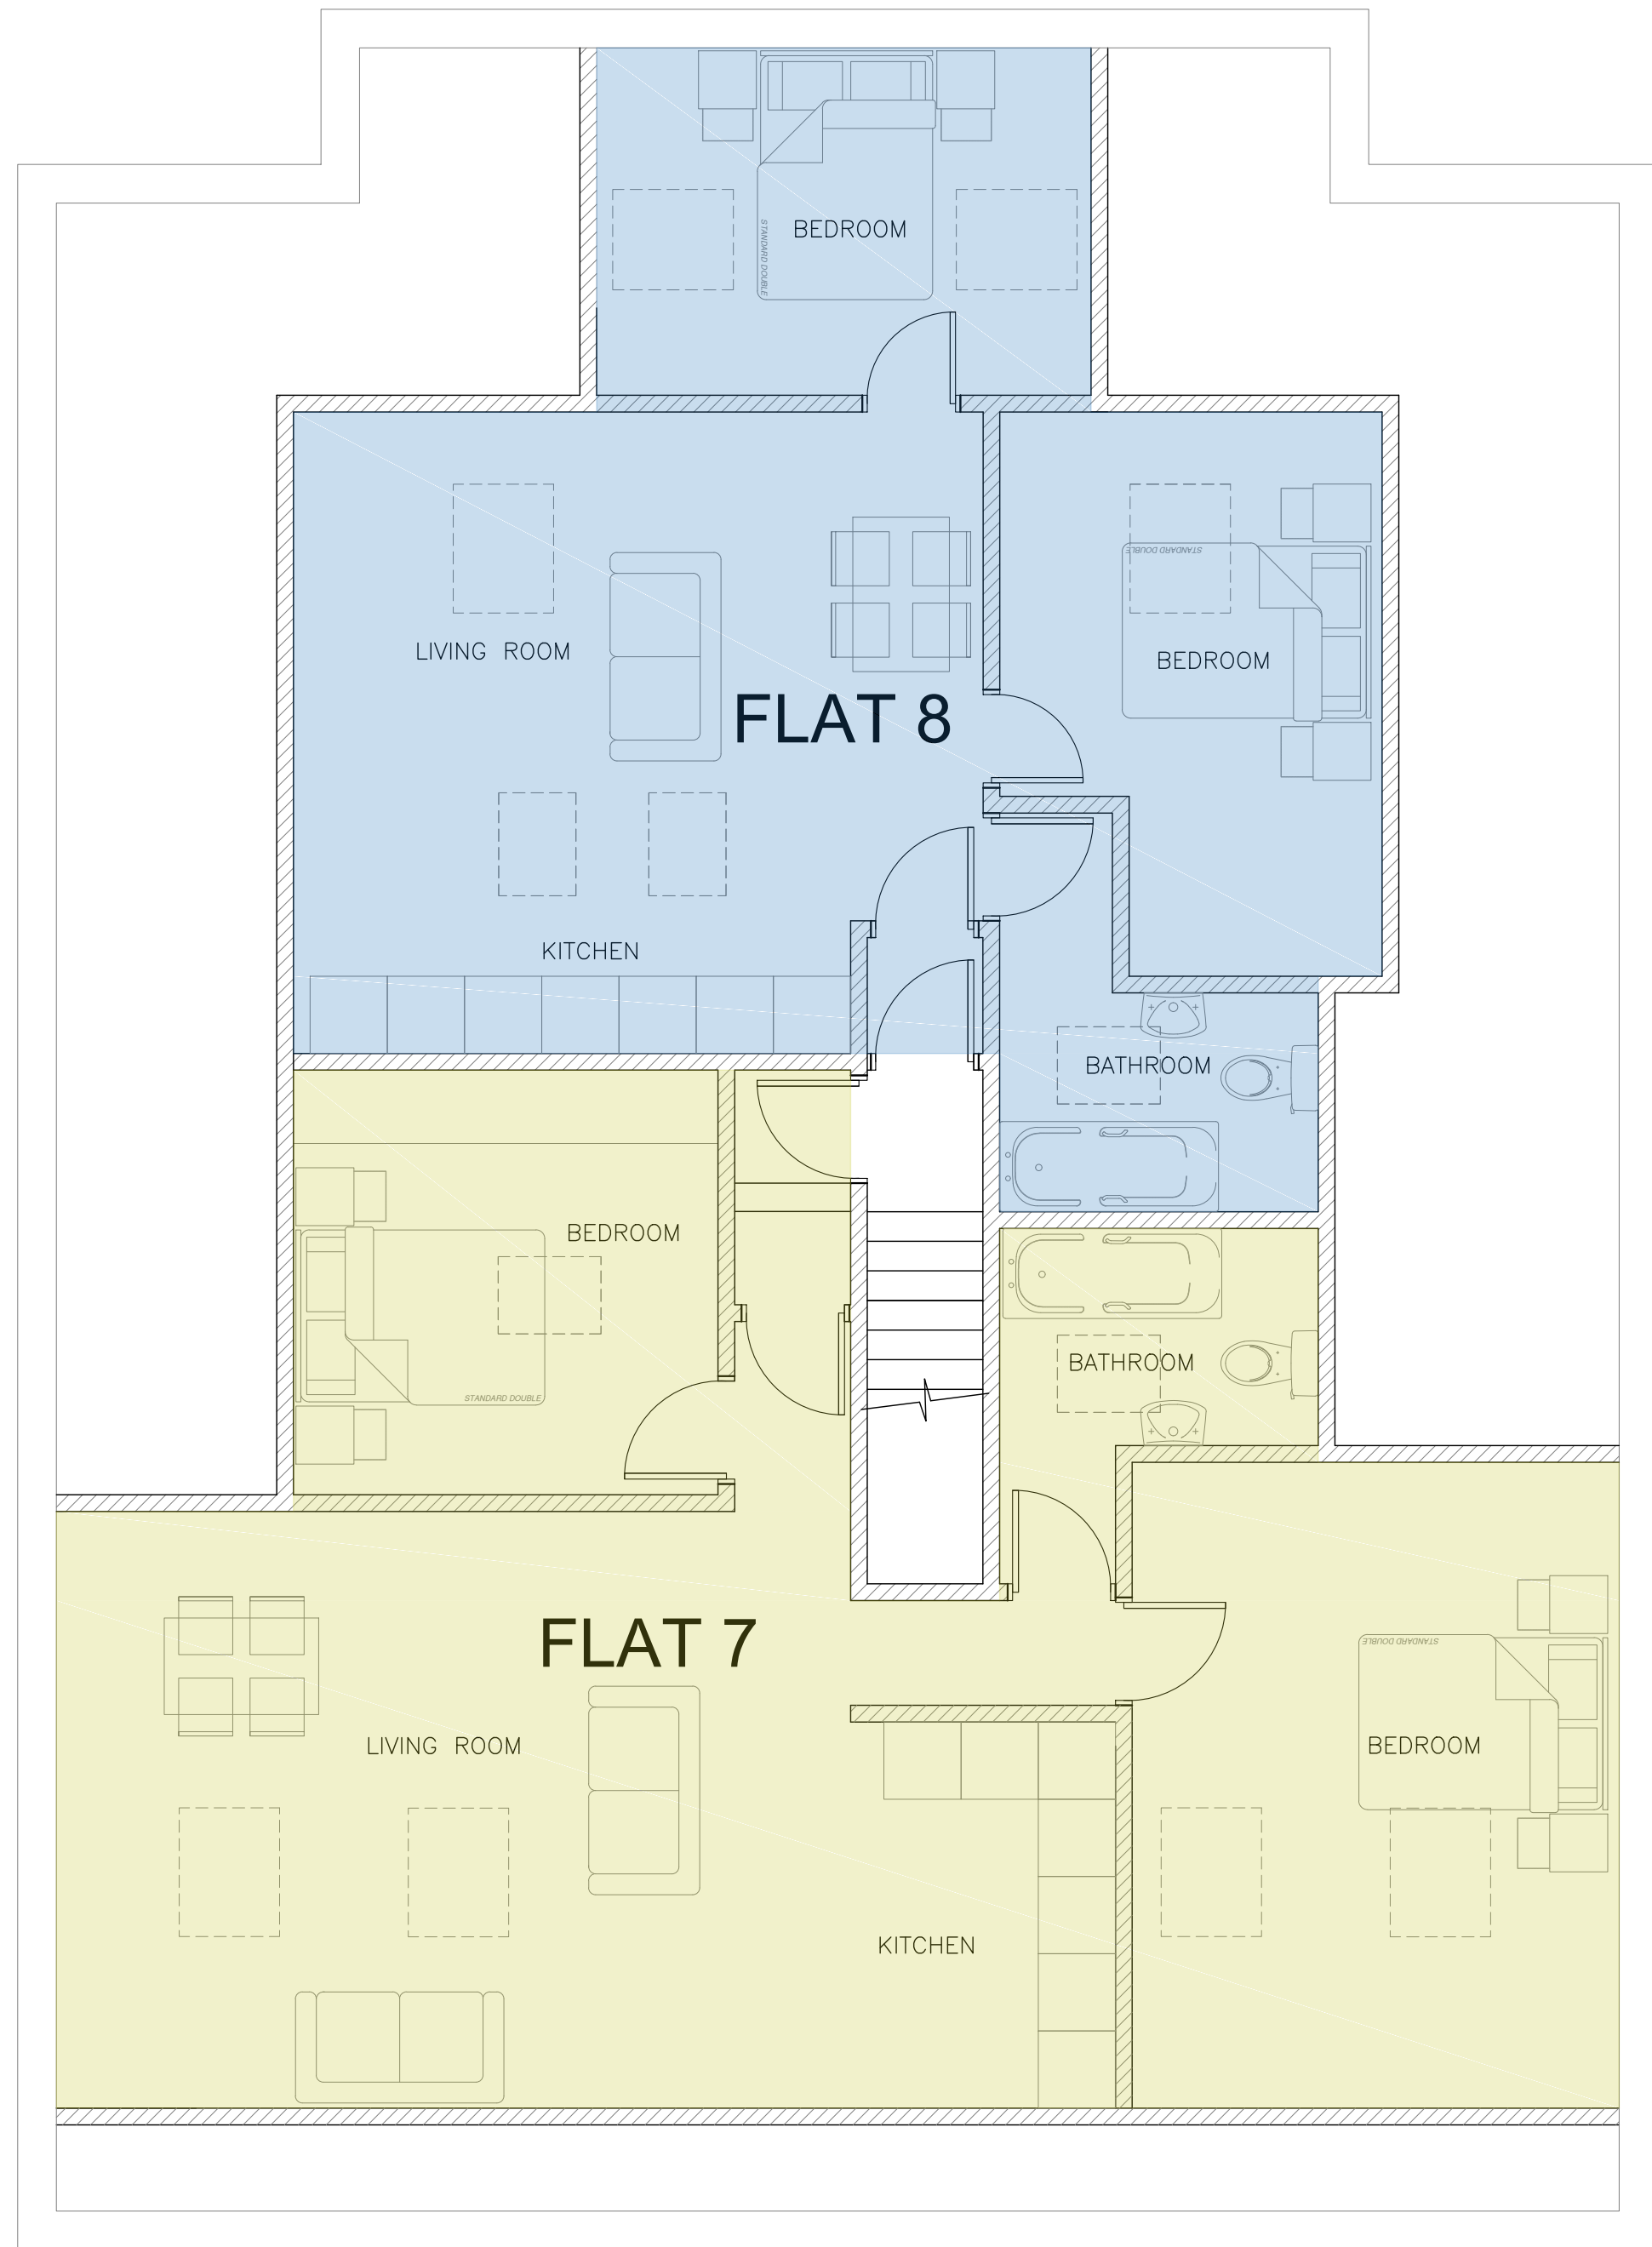

PROPOSED LOFT FLOOR LAYOUT
SCALE 1:50

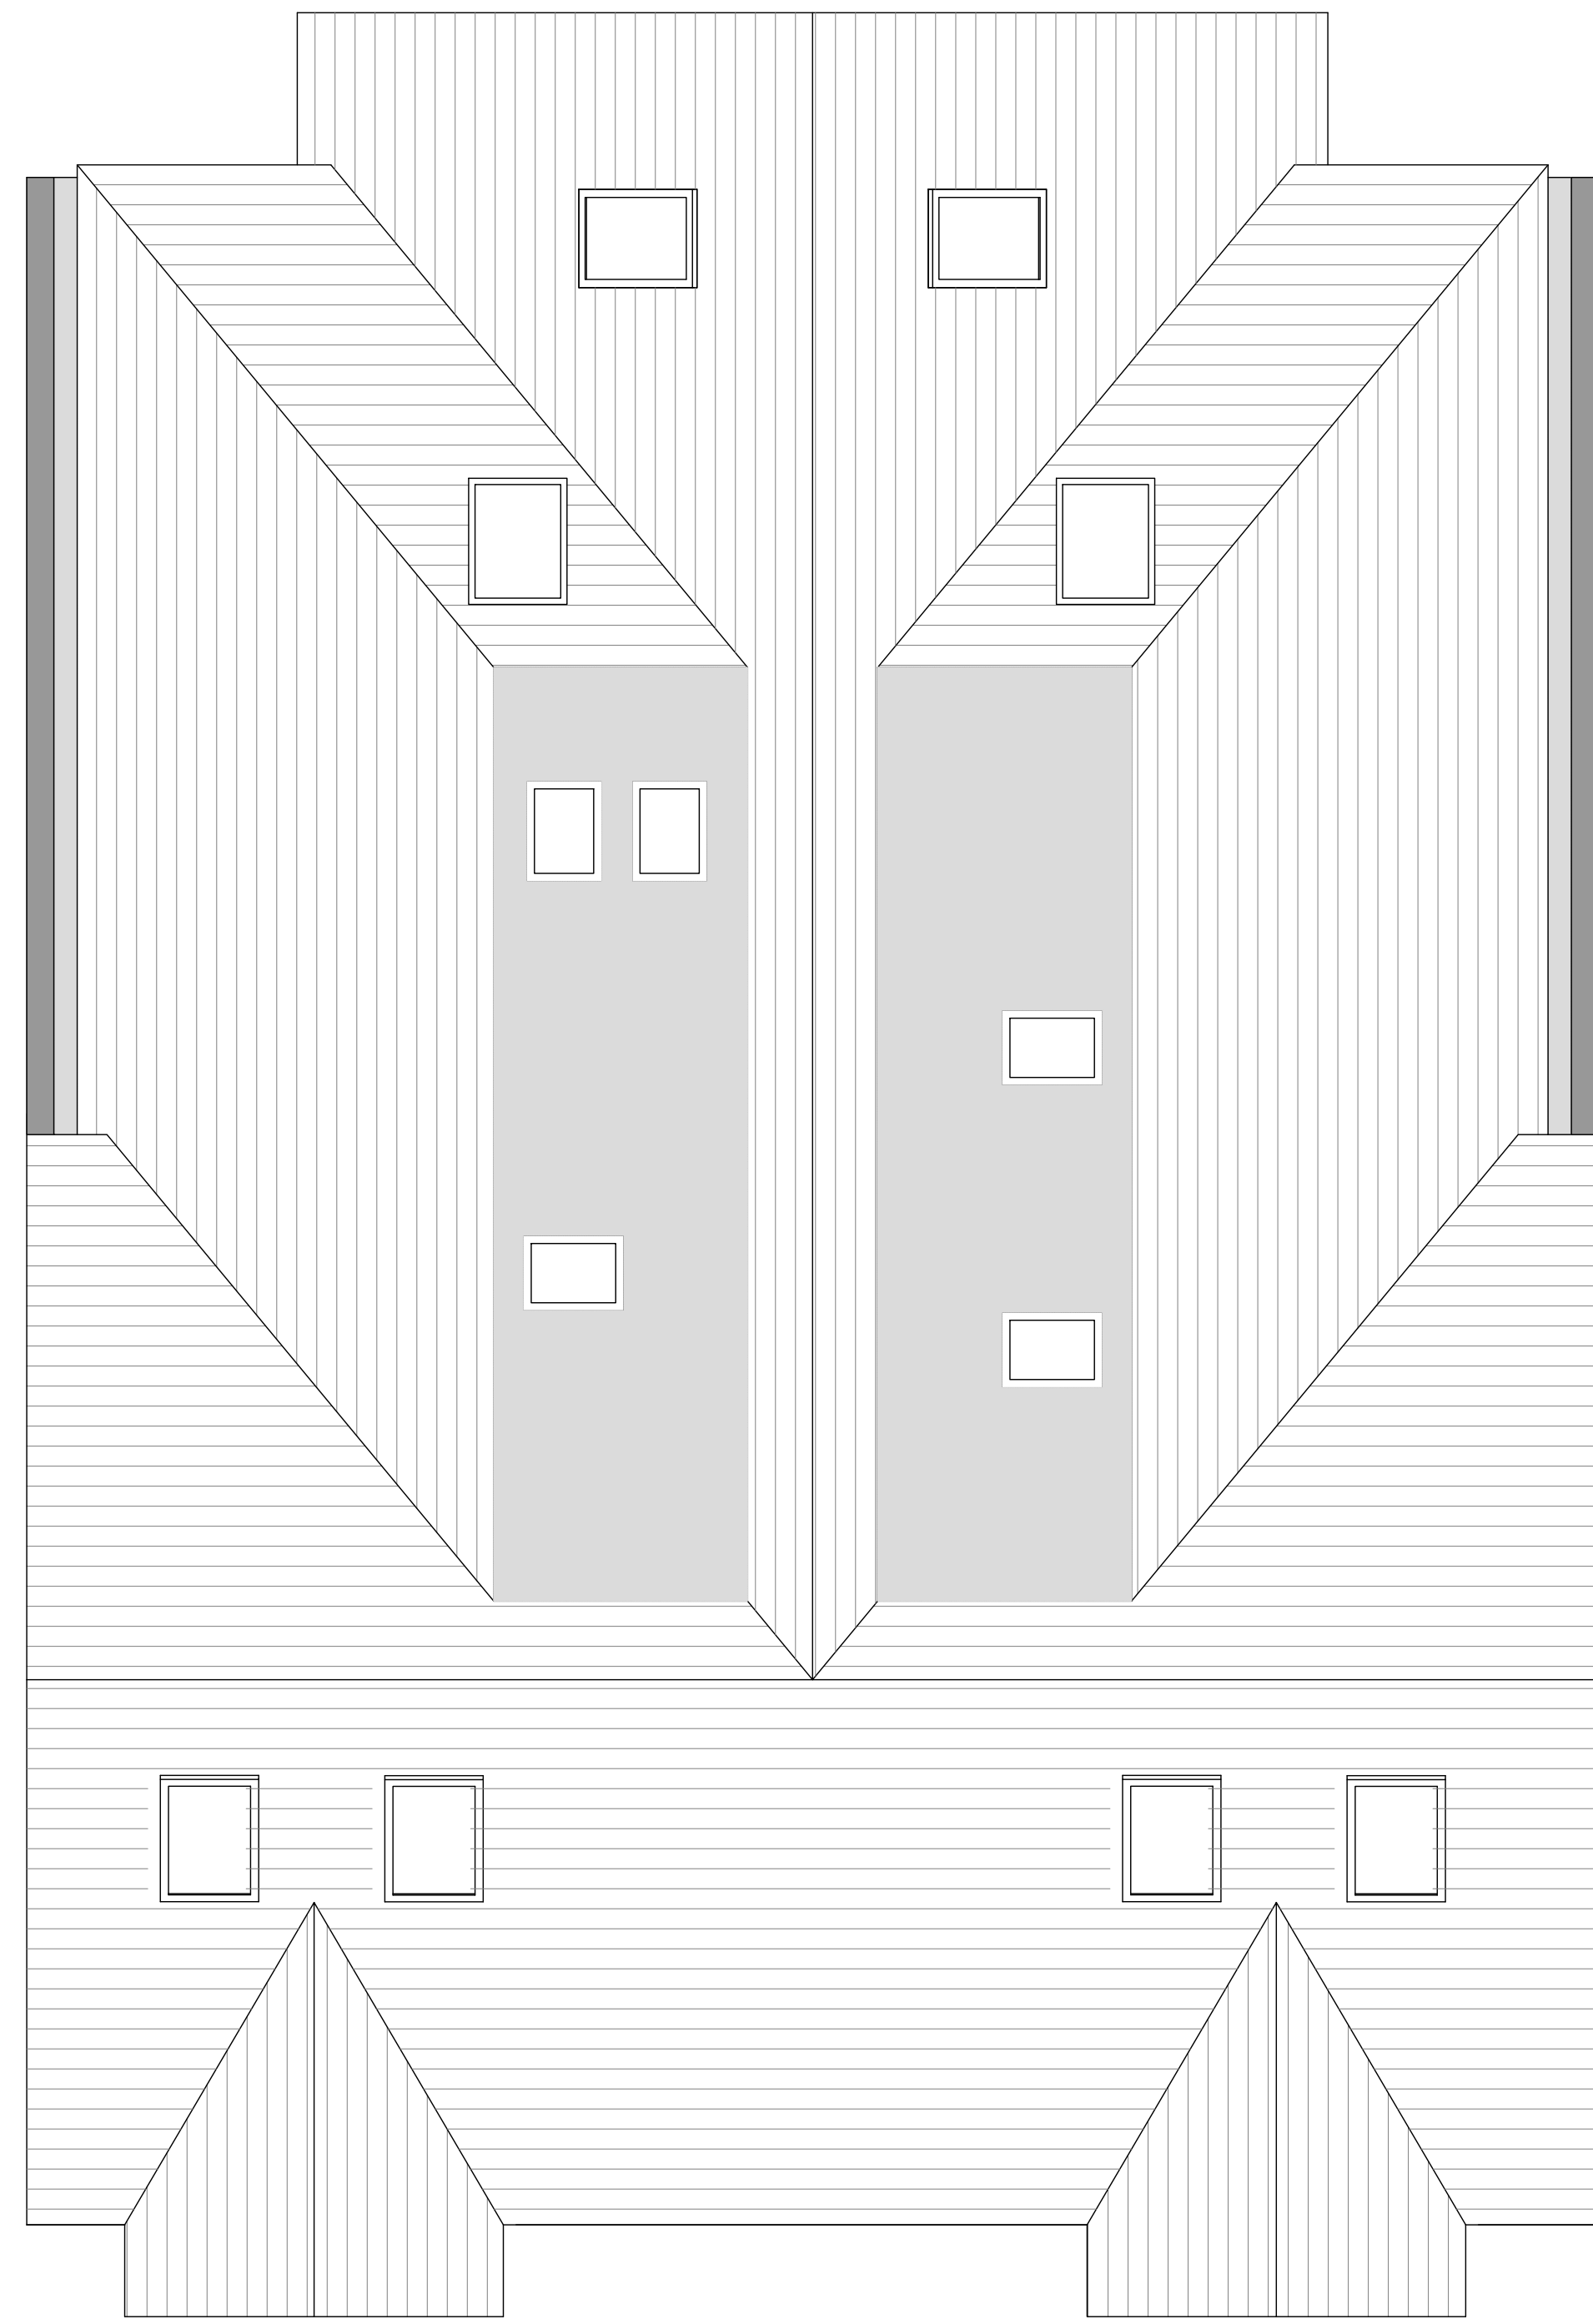

PROPOSED ROOF PLAN
SCALE 1:50

REFERENCE DRAWINGS			
REV	DATE	REVISION	OR REVIEW

Orange Key
 Unit 4, The Cuttings
 120 High Street, Hungerford
 Berkshire, RG17 0LU
 Tel: (01488) 662918
 E-mail: info@orangekeyltd.co.uk

Client
CASTLE HOMES (LONDON) LTD

Project
**106-108 ST LEONARDS ROAD
WINDSOR
SL4 3DD**

Title
**PROPOSED LOFT FLOOR
LAYOUT AND ROOF PLAN**

Scale AS SHOWN @ A1 Date JAN 2016
 Originator Reviewed By GEL


Drawing number 16004/002 Rev. P7

ORIGINAL SCALE 0-100mm

THIS DRAWING IS THE COPYRIGHT OF ORANGE KEY LTD. IT IS PRIVATE AND CONFIDENTIAL AND IS SUPPLIED ON THE EXPRESS CONDITION THAT IT IS NOT USED FOR ANY PURPOSE OR COPIED OR COMMUNICATED TO ANY OTHER PARTY WITHOUT THE WRITTEN CONSENT OF ORANGE KEY LTD.



LIGHTING	
SYMBOL	DESCRIPTION
	TWIN SWITCHED SOCKET OUTLET
	SHAVER SOCKET
	TV AERIAL POINT

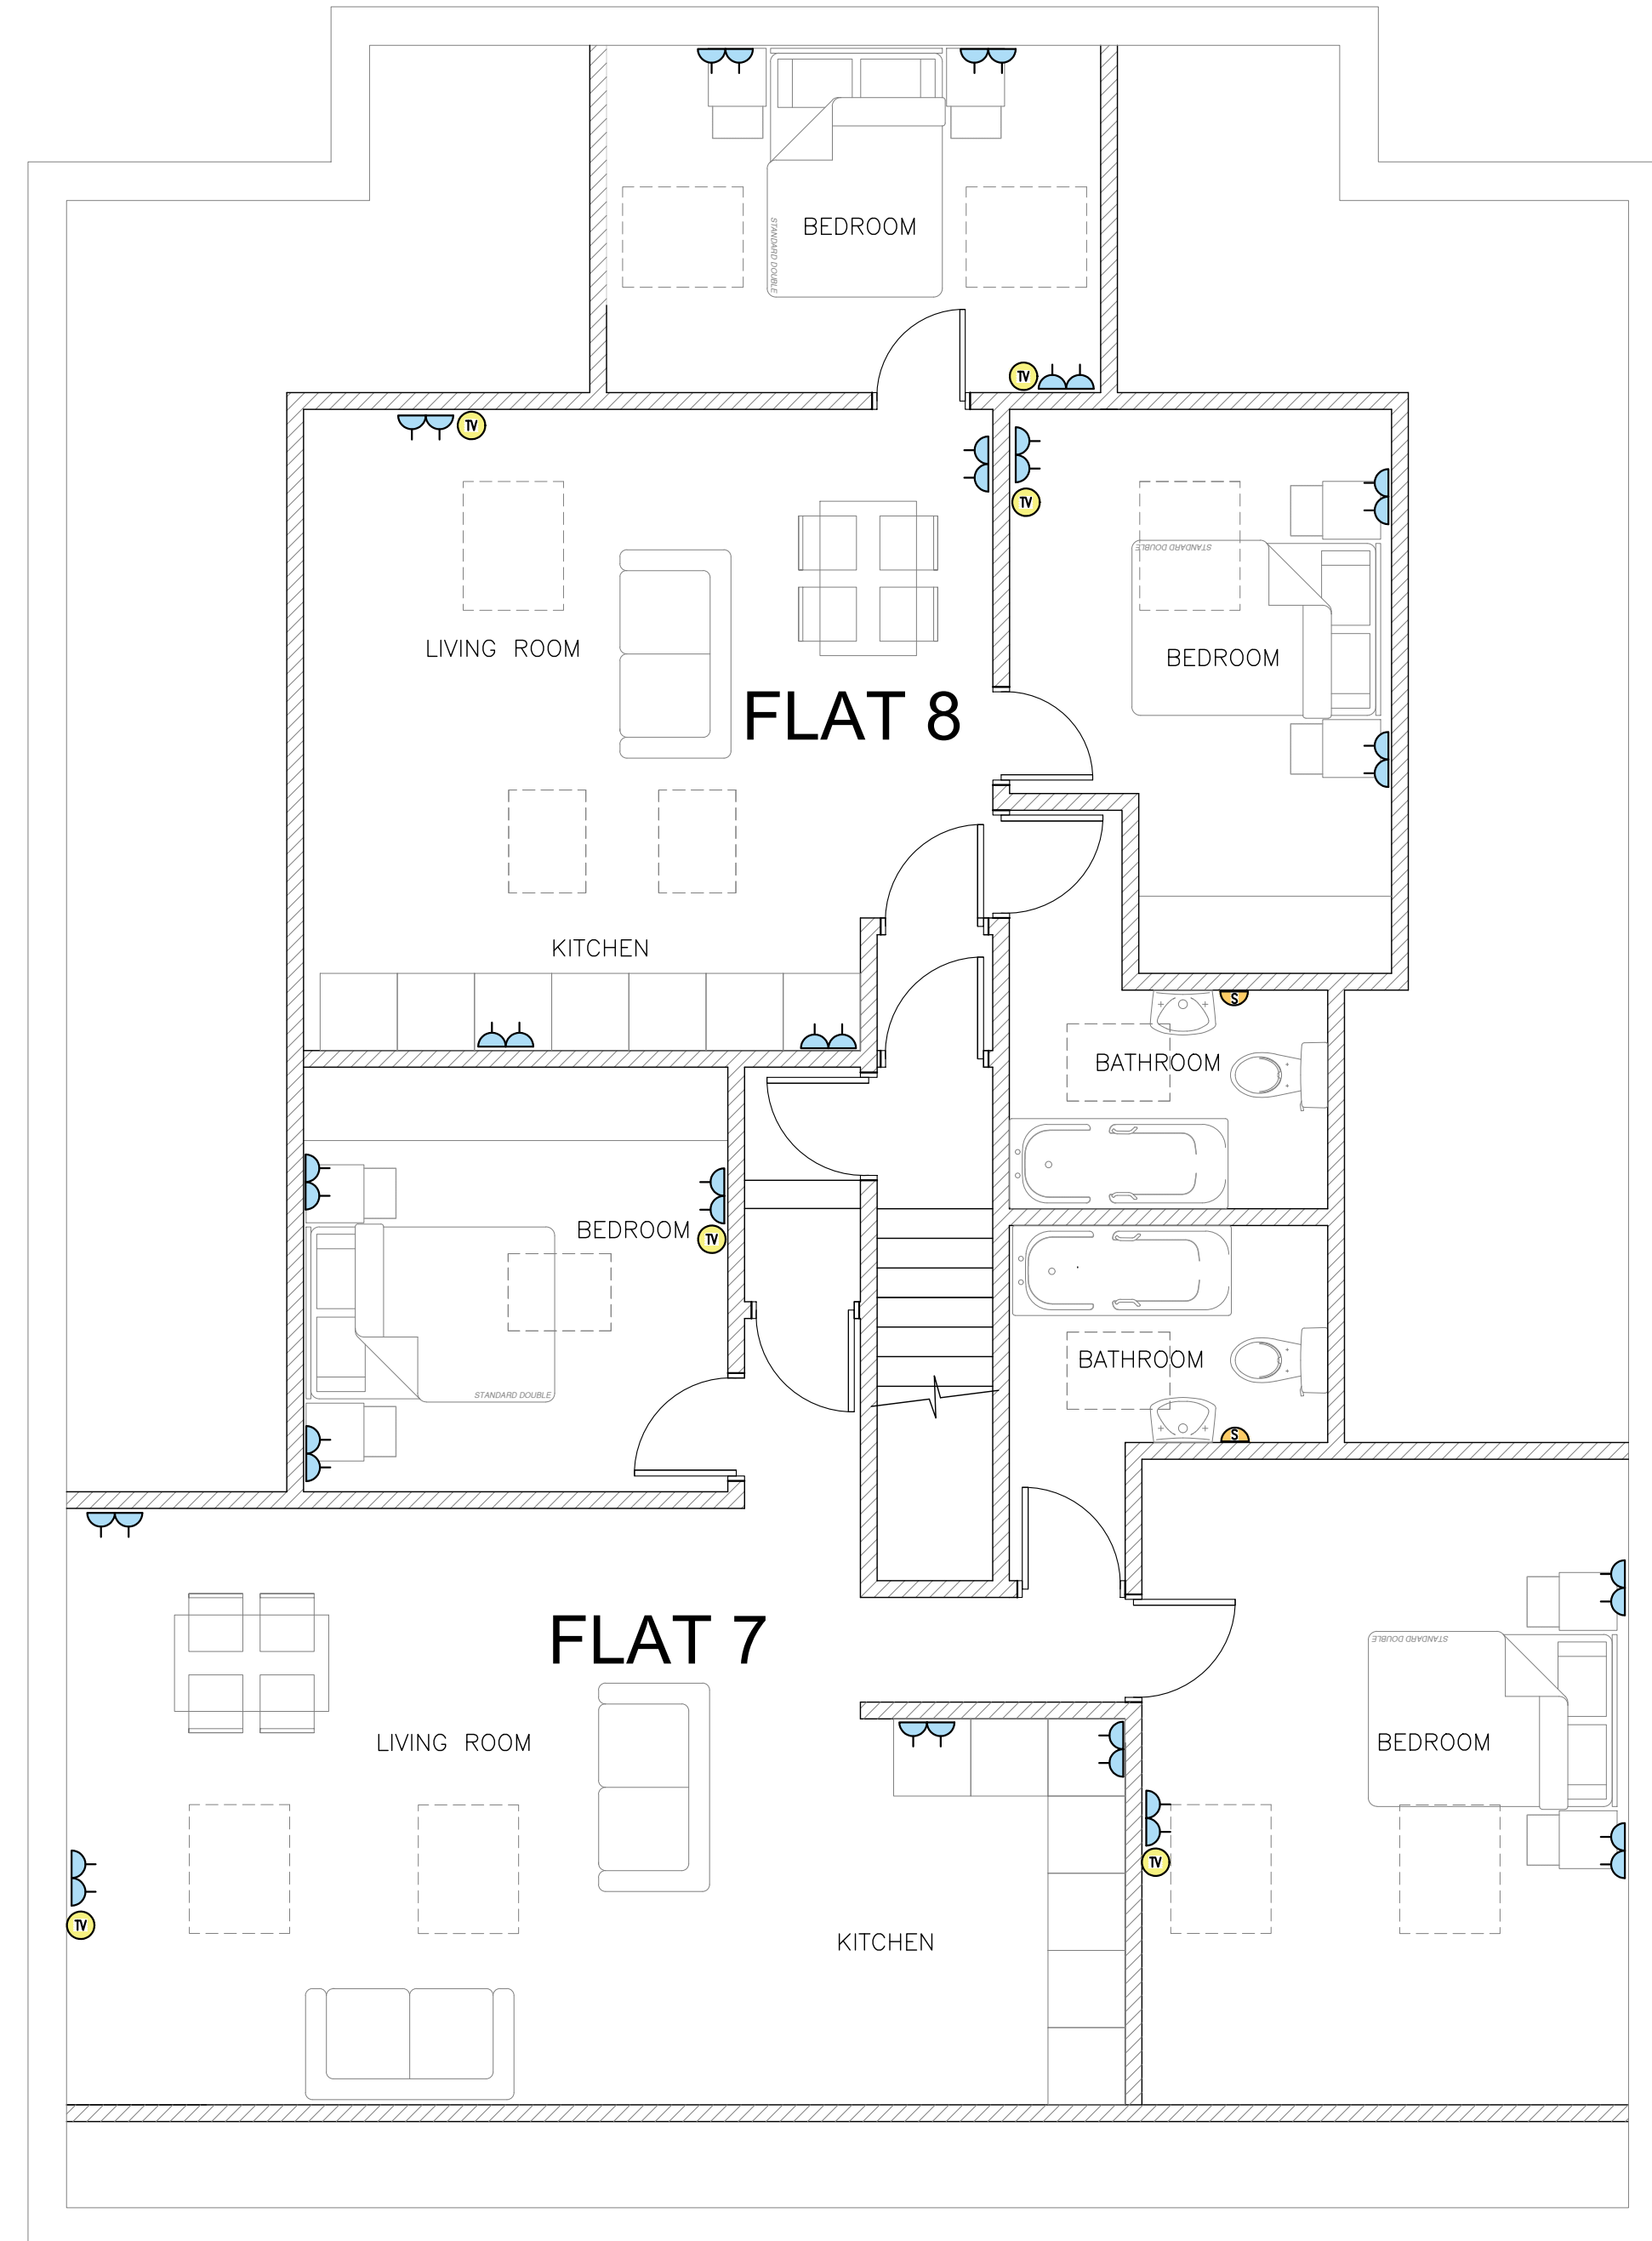

PROPOSED LOFT FLOOR LAYOUT
SCALE 1:50

REFERENCE DRAWINGS			
REV	DATE	REVISION	OR REVIEW

Orange Key
 Unit 4, The Cuttings
 120 High Street, Hungerford
 Berkshire, RG17 0LU
 Tel: (01488) 662918
 E-mail: info@orangekeyltd.co.uk


Client	CASTLE HOMES (LONDON) LTD
Project	106-108 ST LEONARDS ROAD WINDSOR SL4 3DD
Title	LOFT FLOOR SOCKET AND TV POINT LAYOUT
Scale	AS SHOWN @ A1
Date	SEP 2016
Originator	Reviewed By GEL
Drawing number	Rev.
16004/EL05	P1

ORIGINAL SCALE 0-100mm

THIS DRAWING IS THE COPYRIGHT OF ORANGE KEY LTD. IT IS PRIVATE AND CONFIDENTIAL AND IS SUPPLIED ON THE EXPRESS CONDITION THAT IT IS NOT USED FOR ANY PURPOSE OR COPIED OR COMMUNICATED TO ANY OTHER PARTY WITHOUT THE WRITTEN CONSENT OF ORANGE KEY LTD.



LIGHTING	
SYMBOL	DESCRIPTION
	LIGHT SWITCH
	FULL CORD LIGHT SWITCH
	LOW VOLTAGE DOWNLIGHT
	LOW VOLTAGE DIRECTIONAL DOWNLIGHT
	CENTRE LIGHT
	PENDANT LIGHT
	WALL MOUNTED LUMINAIRE
	EXTRACTOR FAN
	FLORESCENT TUBE LUMINAIRE
	SECURITY LIGHT WITH SENSOR
	SINGLE SWITCHED SOCKET OUTLET
	TWIN SWITCHED SOCKET OUTLET
	DISHWASHER SWITCHED SOCKET OUTLET
	TUMBLE DRYER SWITCHED SOCKET OUTLET
	WASHING MACHINE SWITCHED SOCKET OUTLET
	SHAVER SOCKET
	TV AERIAL POINT
	SATELLITE POINT
	BT OUTLET

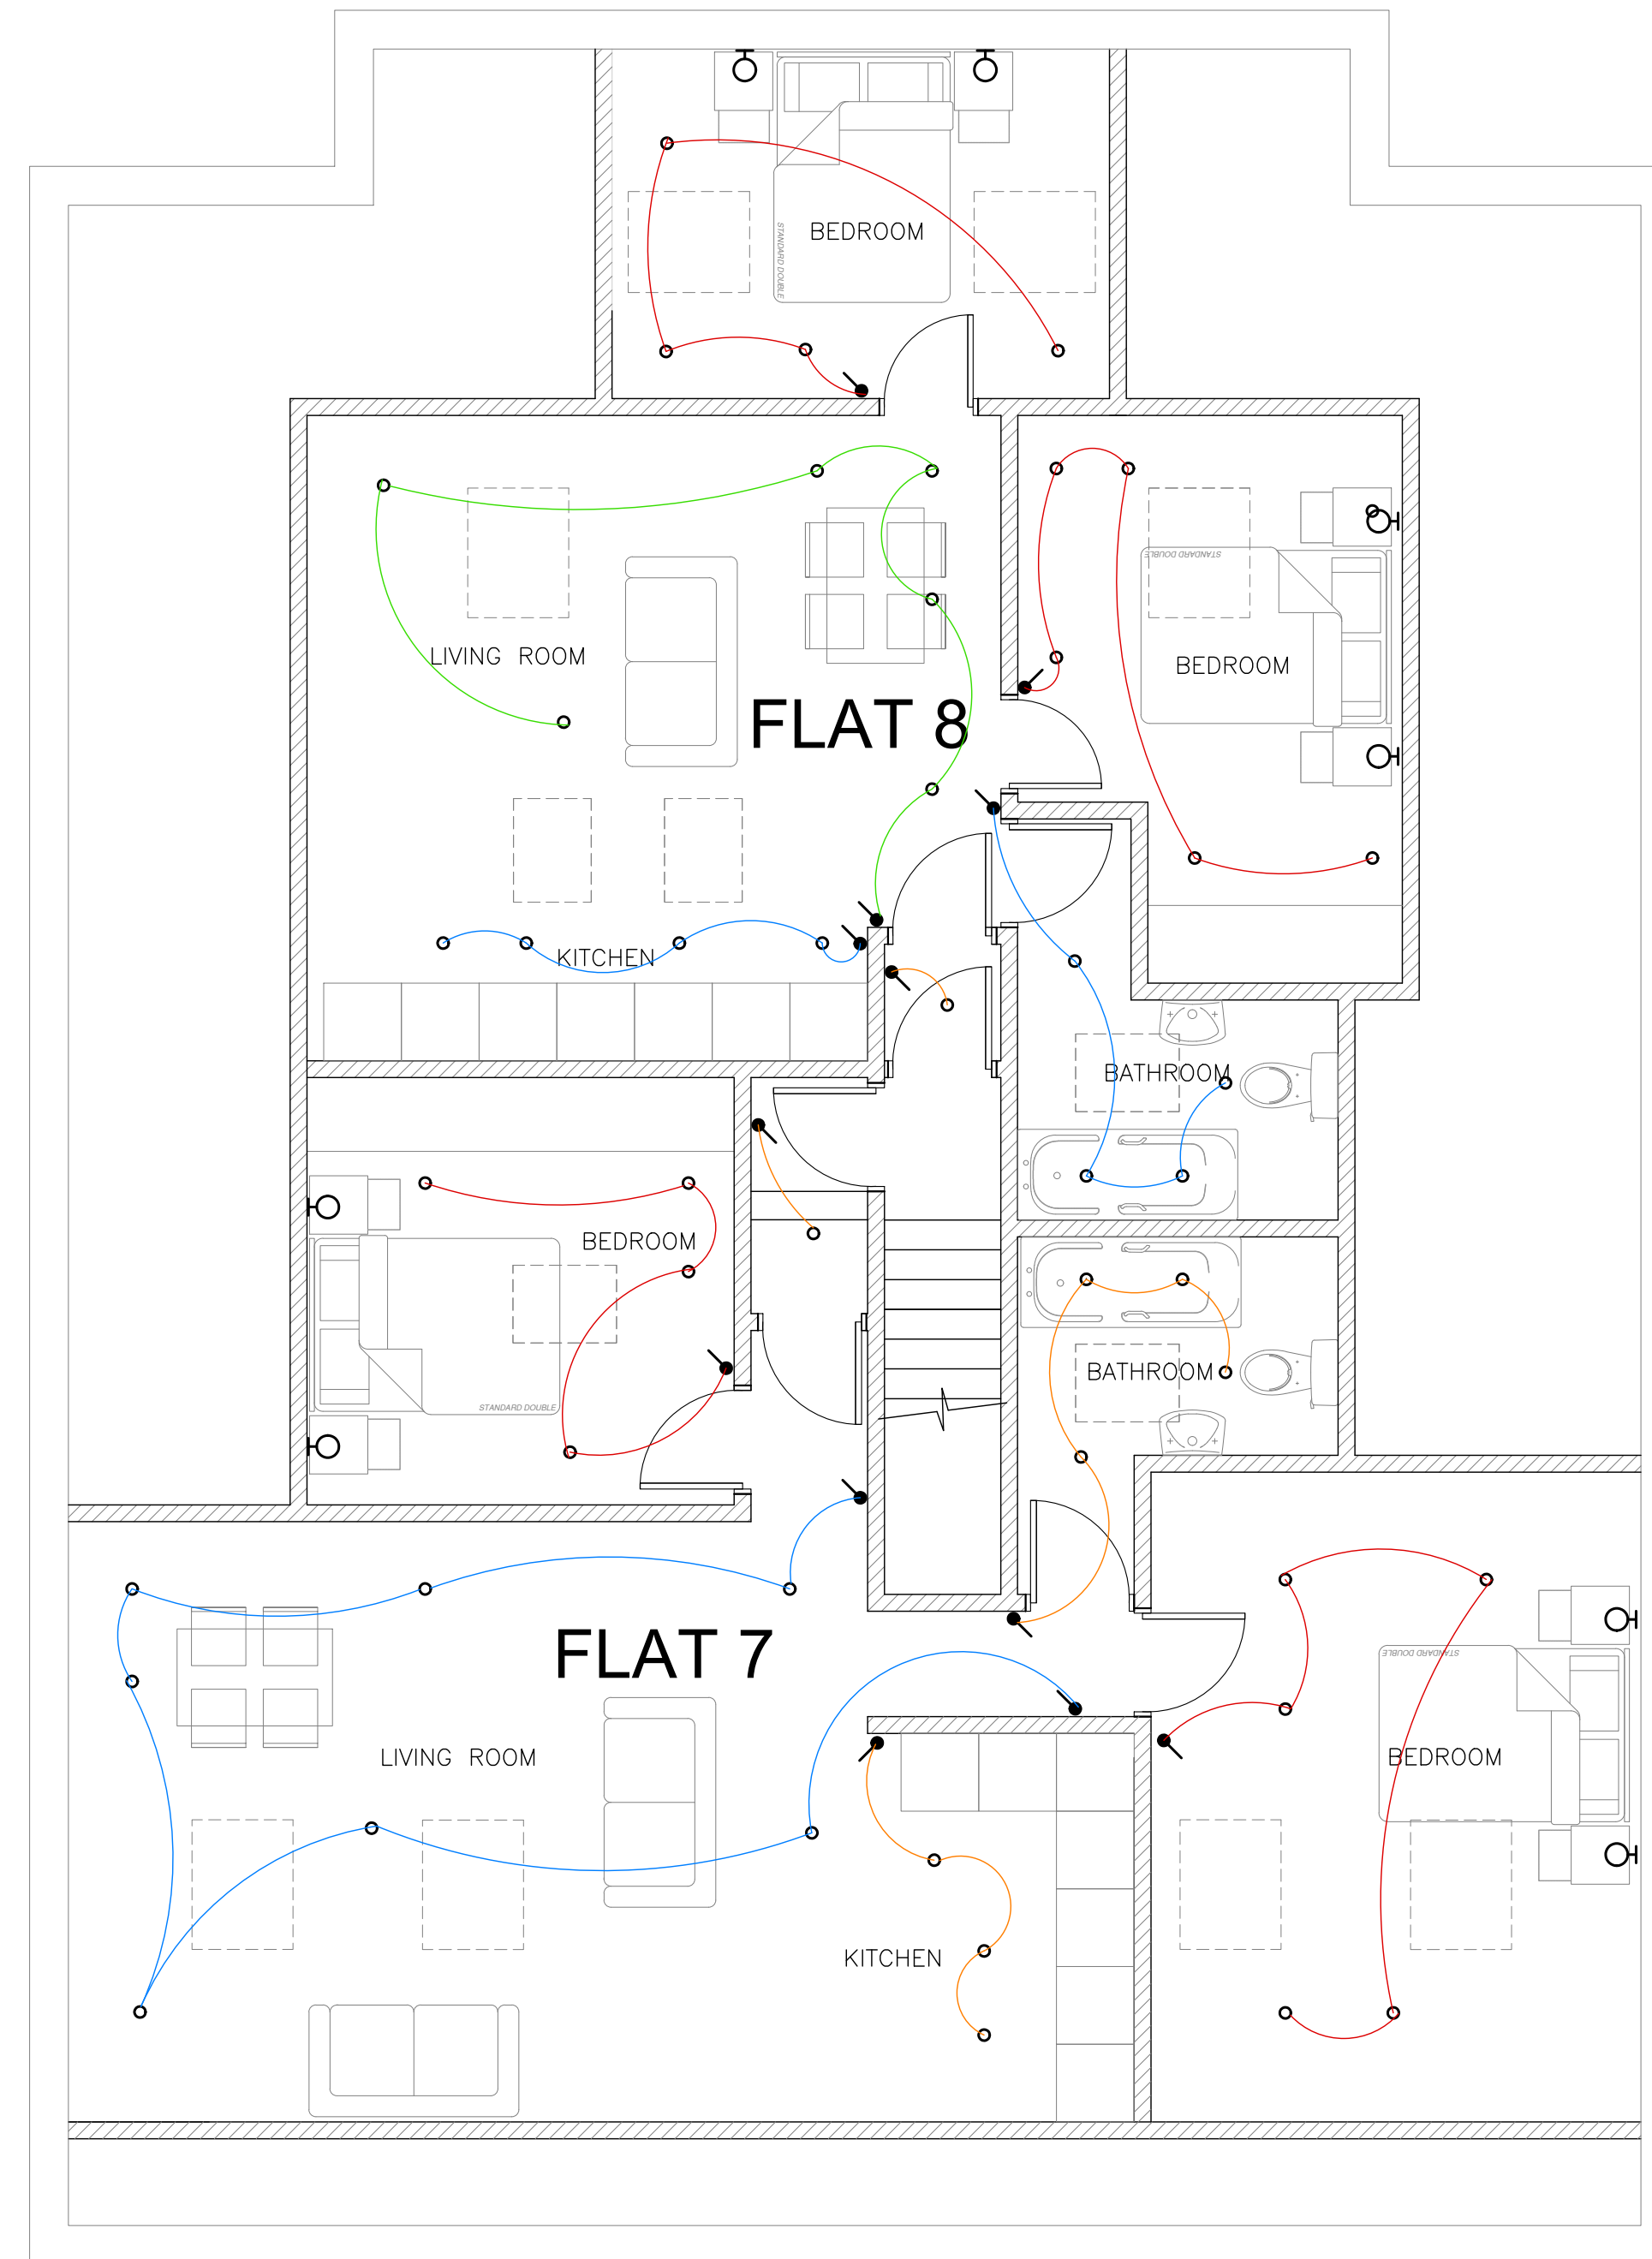

PROPOSED LOFT FLOOR LAYOUT
SCALE 1:50

REFERENCE DRAWINGS			
REV	DATE	REVISION	OR REVIEW

--	--	--	--

Orange Key
 Unit 4, The Cuttings
 120 High Street, Hungerford
 Berkshire, RG17 0LU
 Tel: (01488) 662918
 E-mail: info@orangekeyltd.co.uk

Client	CASTLE HOMES (LONDON) LTD
Project	106-108 ST LEONARDS ROAD WINDSOR SL4 3DD
Title	LOFT FLOOR LIGHTING LAYOUT

Scale	AS SHOWN @ A1	Date	SEP 2016
Originator		Reviewed By	GEL

Drawing number	16004/EL06	Rev.	P1
----------------	------------	------	----

ORIGINAL SCALE 0-100mm